
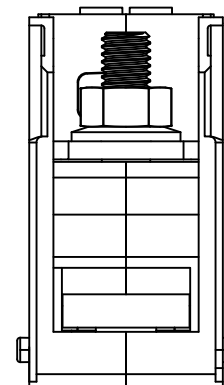
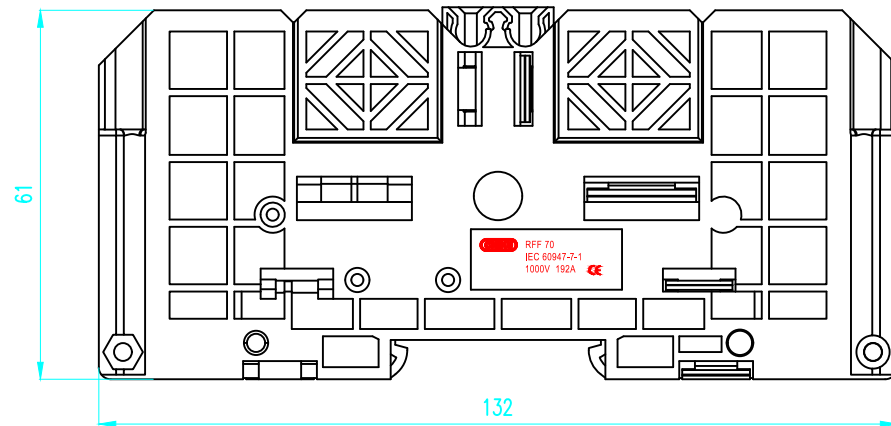
 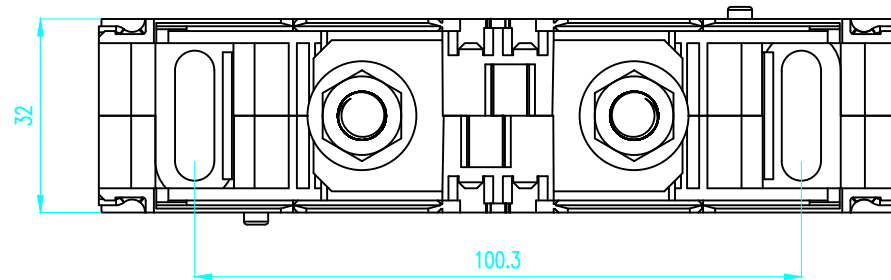


额定电压 Rated voltage (V)	1000
额定电流 Rated current (A)	192
适配电线截面 Wire range (mm ²)	2.5-70
工作温度 Operating temperature(℃)	-40~+105



未注公差undefined tol 0--10±0.3 >10--30±0.5 >30--100±1.0 >100--250±1.5 >250±1% 未注角度公差undefined angle ±2° 未注尺寸单位undefined size mm	设计design	-	-	江西航同电气科技有限公司 Jiangxi Huntect Electrical Technology Co.,Ltd.	
	审核check	-	-		
	批准approve	-	-		
	材料material	见表格 see table		名称 name	Doubel Stud Terminal Block
	重量WT. (g)	/	比例scale 1:125	型号 spc.	RFF70
	第三视角 	图幅size A4	料号 PN.	-	
3rd angle projection	页码sheet 1 / 1	图号dwg No.	-		